


Revision Table:

Rev. No.	Date	By	Description of revision
A	01.08.19	MLC	Basement floor plan added to drawing

Drawing Notes:

-

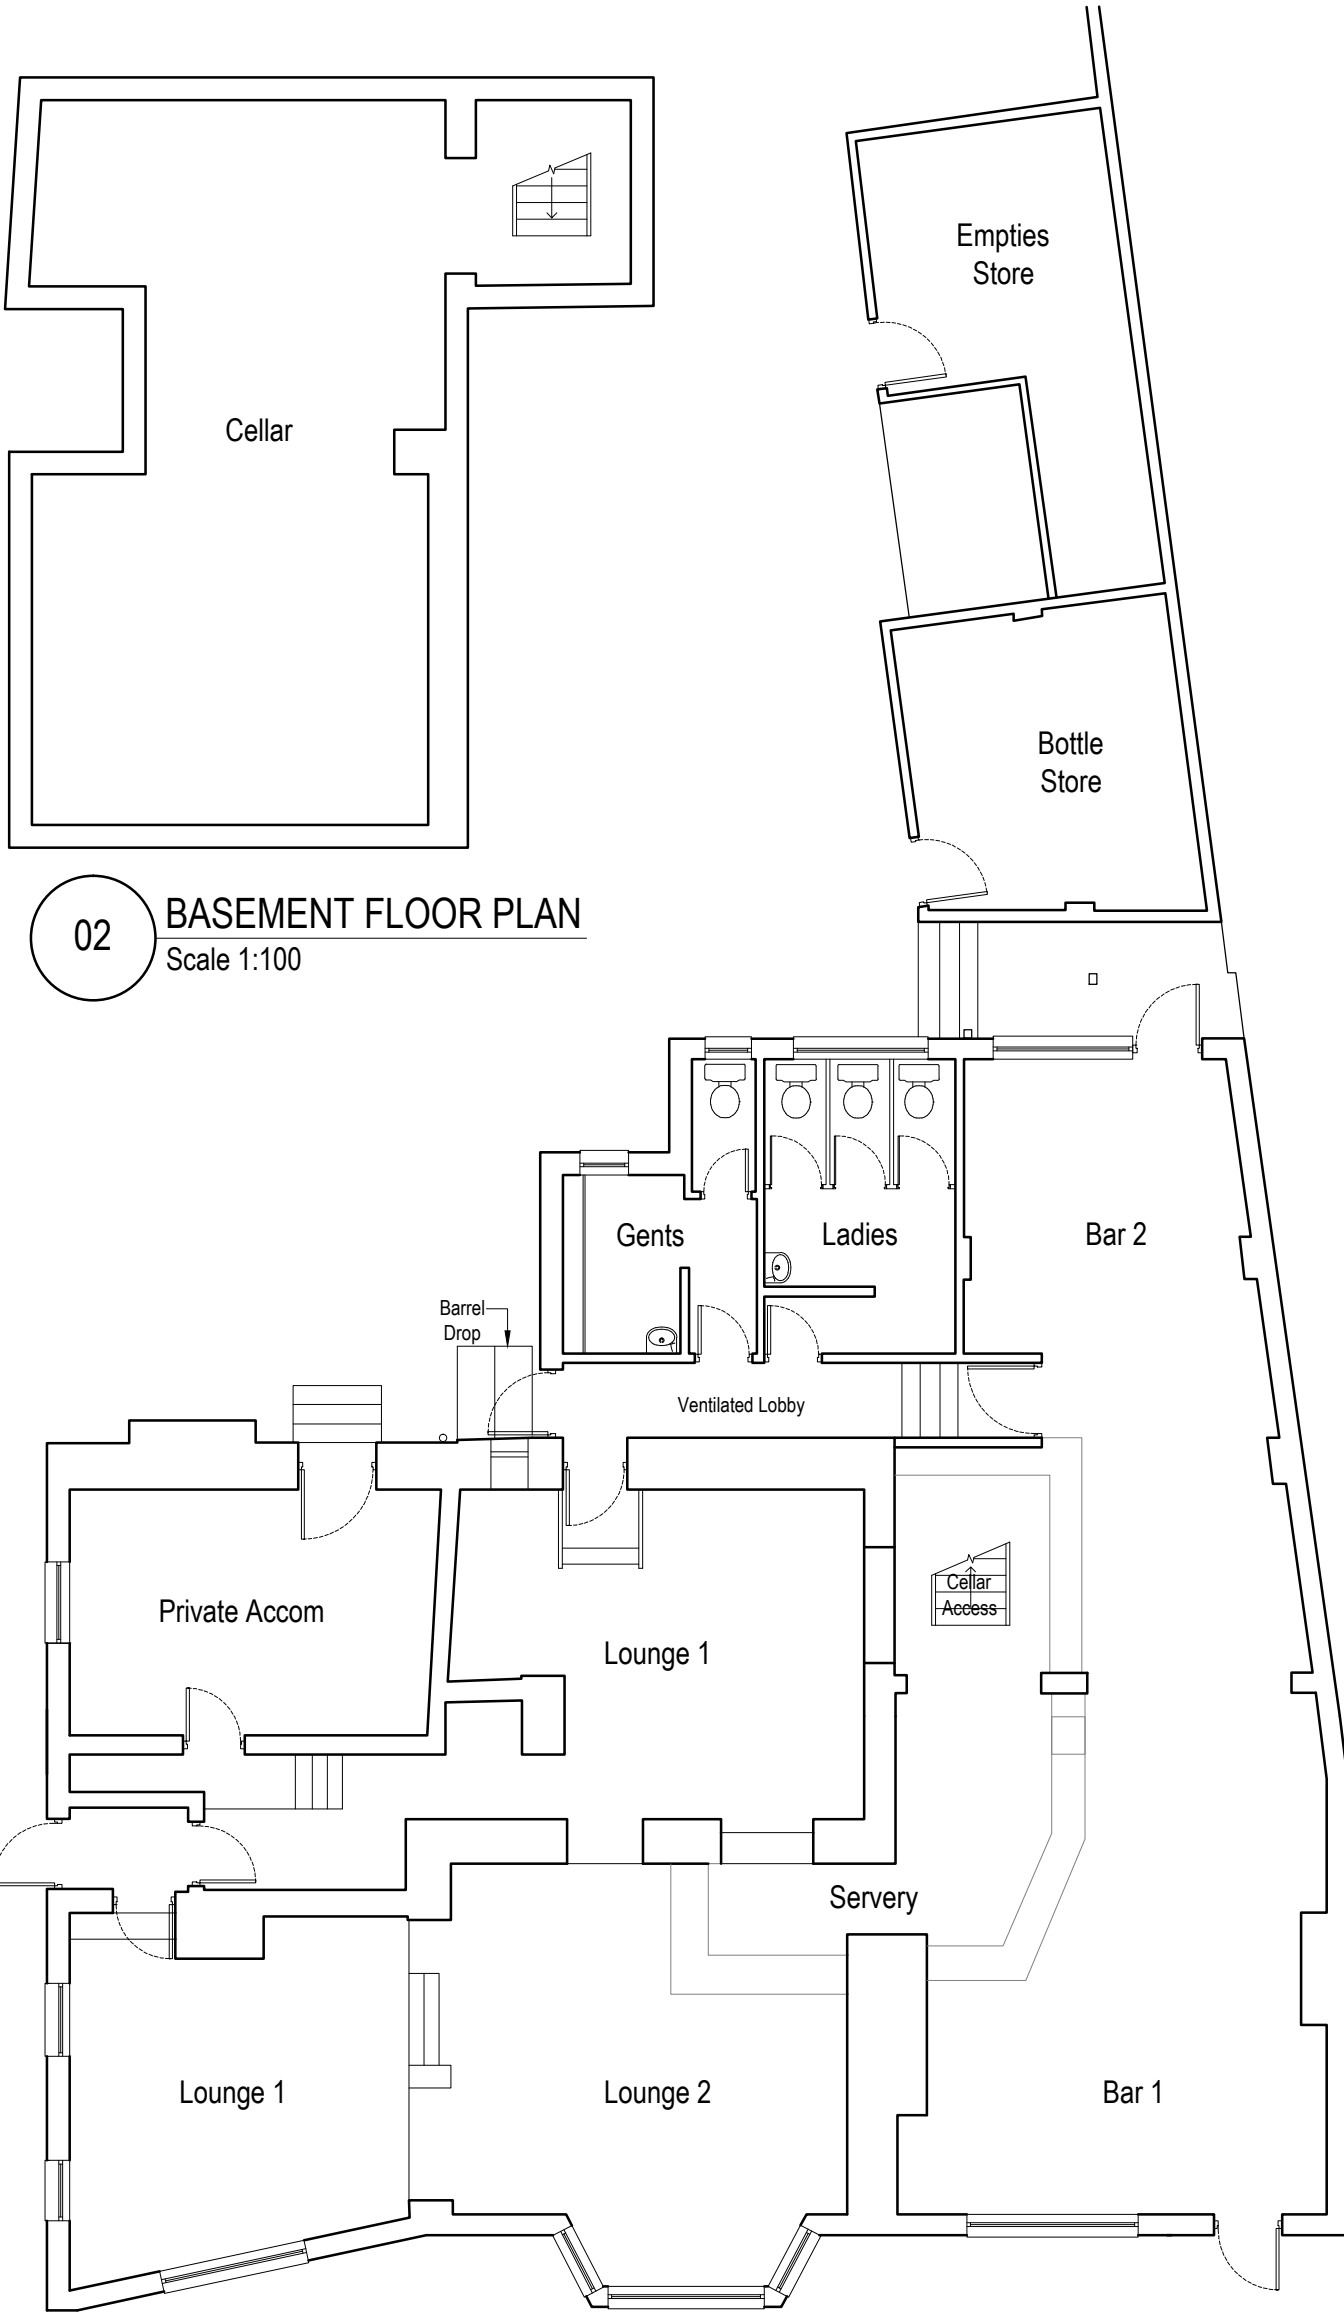

02 BASEMENT FLOOR PLAN
Scale 1:100

01 EXISTING GA FLOOR PLAN
Scale 1:100

fluiddesign

SUITE S1, THE CATALYST, BAIRD LANE, YORK, YO10 5GA
 t: 01904 310 257 e: info@fluiddesignassociates.com w: www.fluiddesignassociates.com
 COMPANY NUMBER: OC 347704 VAT REGISTRATION NUMBER 980 2054 33
 Fluid Design is a trading name of Fluid Associates LLP

Client:
Terry O'Sullivan

Project:
The George Inn, Littlemore

Drawing Title: Licencing Plan
Drawing Status: Planning

Job No: SUL047
Rev No: A
Drawing Number: DE(9)001

Date: July 2019
Scale: 1:100@A3
Drawn By: MLC
Checked By: AJ

THIS DRAWING & ALL INFORMATION CONTAINED WITHIN IS THE COPYRIGHT OWNERSHIP OF FLUID ASSOCIATES LLP AND CANNOT BE USED BY ANY OTHER PARTY UNLESS AGREED WITHOUT PRIOR PERMISSION IN WRITING FROM FLUID ASSOCIATES LLP - ALL DIMENSIONS ARE SUBJECT TO A SITE SURVEY - DO NOT SCALE FROM THIS DRAWING - FLUID ASSOCIATES LLP CAN NOT GUARANTEE THE SCALE OF ANY DRAWINGS WHICH ARE CONVERTED TO PDF - ALL DIMENSIONS ARE IN MILLIMETERS UNLESS STATED OTHERWISE - THIS DRAWING SHOULD BE READ IN CONJUNCTION WITH ALL OTHER RELEVANT DRAWINGS AND SPECIFICATIONS - NO PART OF THIS DRAWING IS TO BE REPRODUCED, STORED IN A RETRIEVAL SYSTEM OR TRANSMITTED IN ANY FORM OR BY ANY MEANS WITHOUT PRIOR PERMISSION IN WRITING.